




GROUND FLOOR PLAN
SCALE 1:50

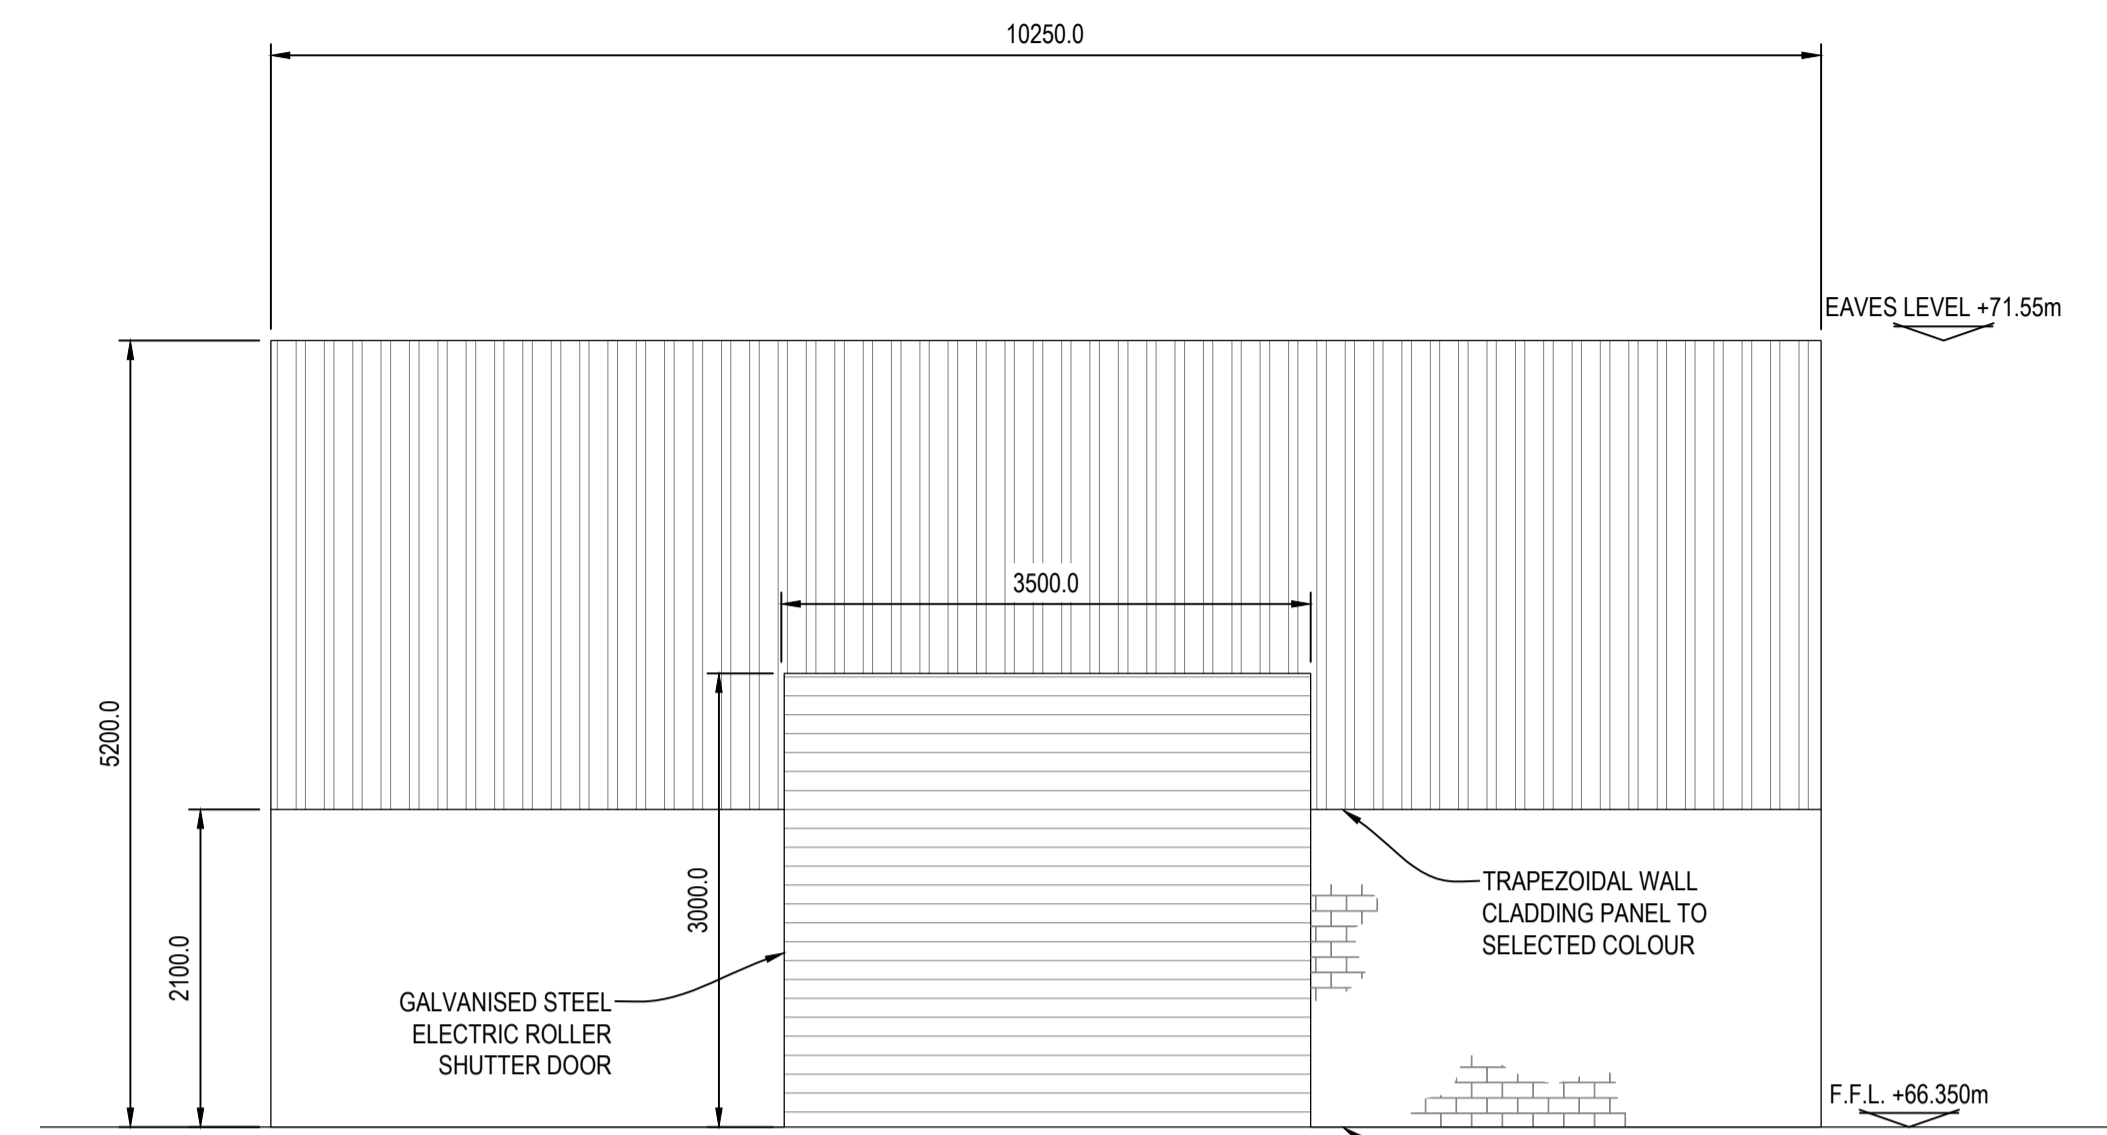


SOUTH ELEVATION
SCALE 1:50

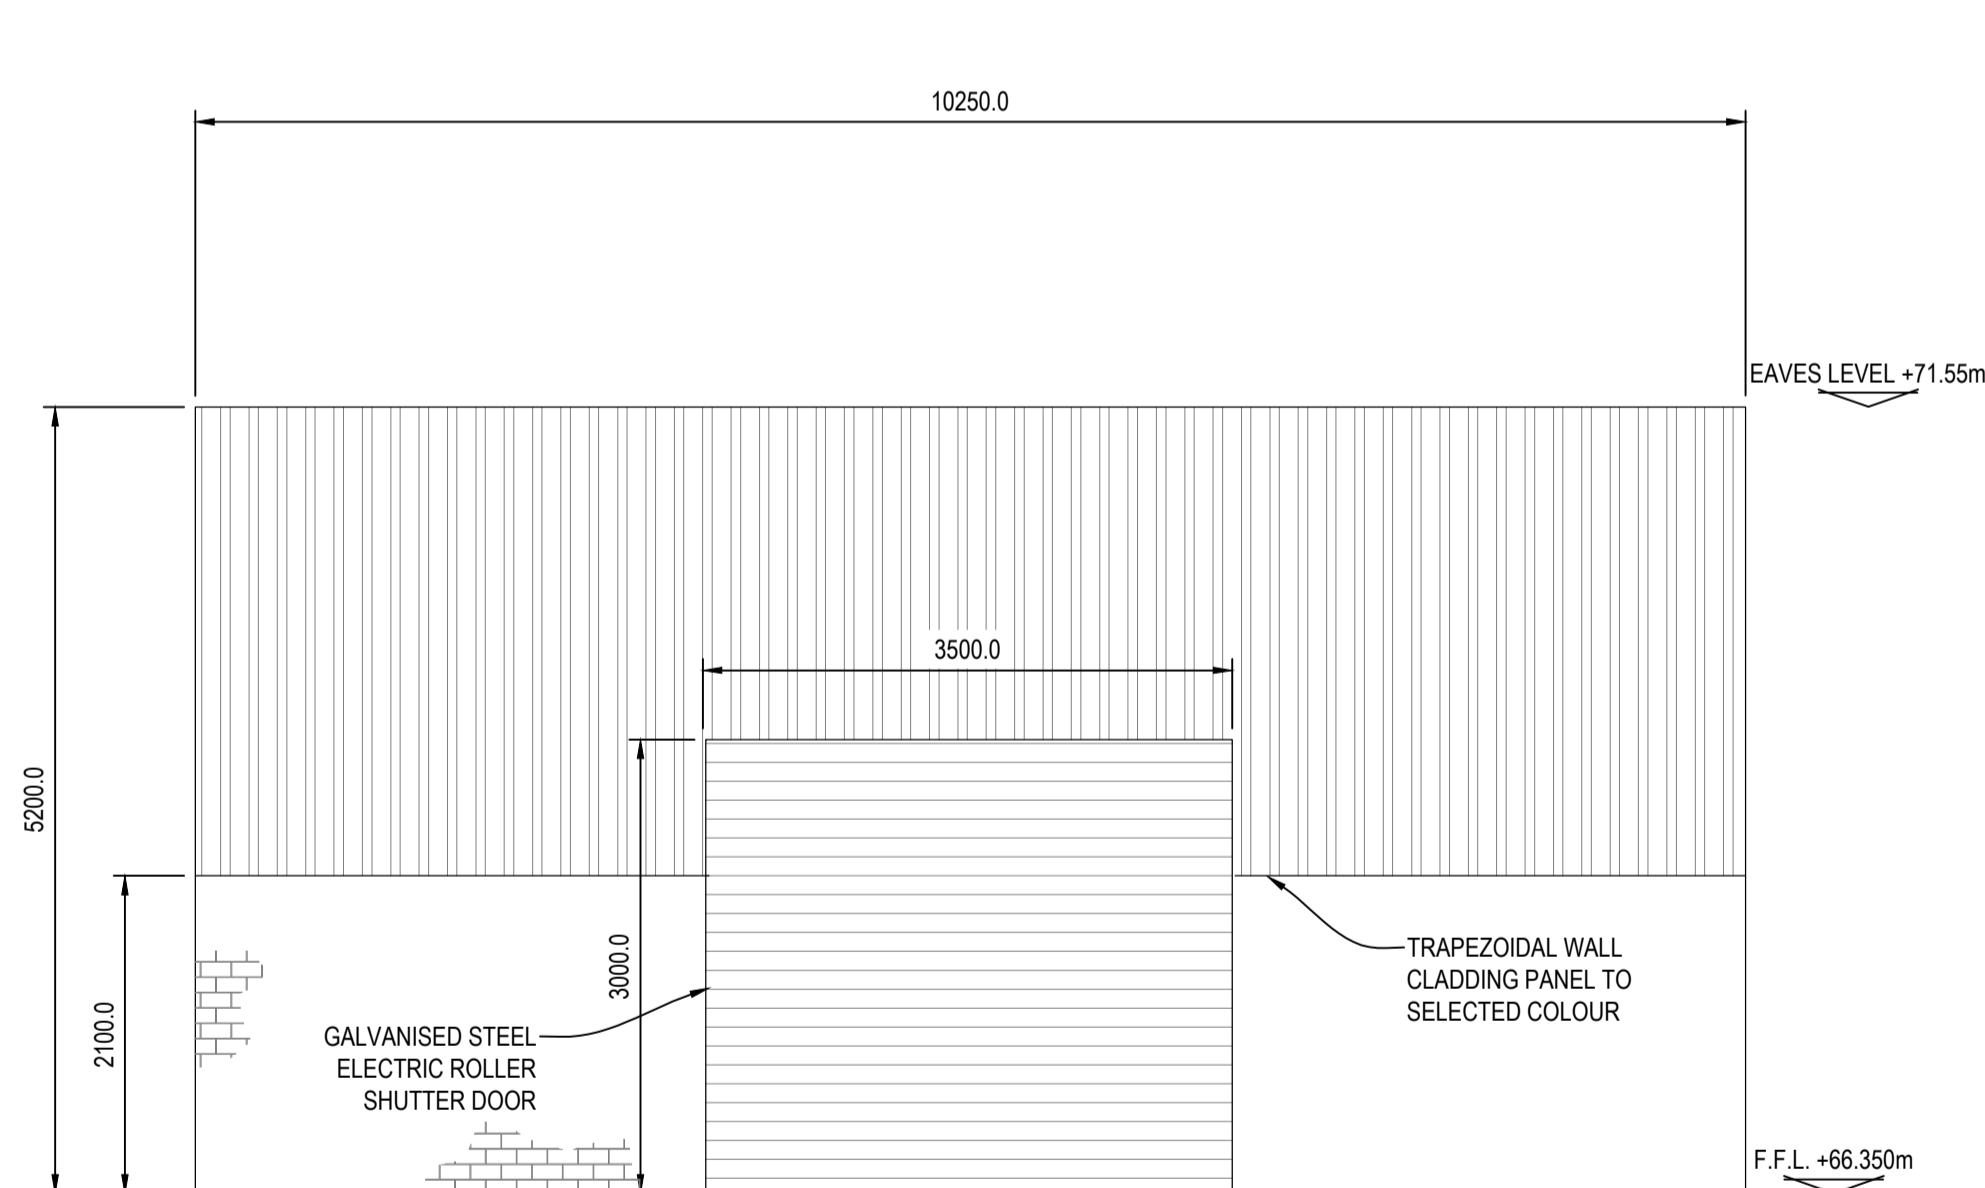


NORTH ELEVATION
SCALE 1:50

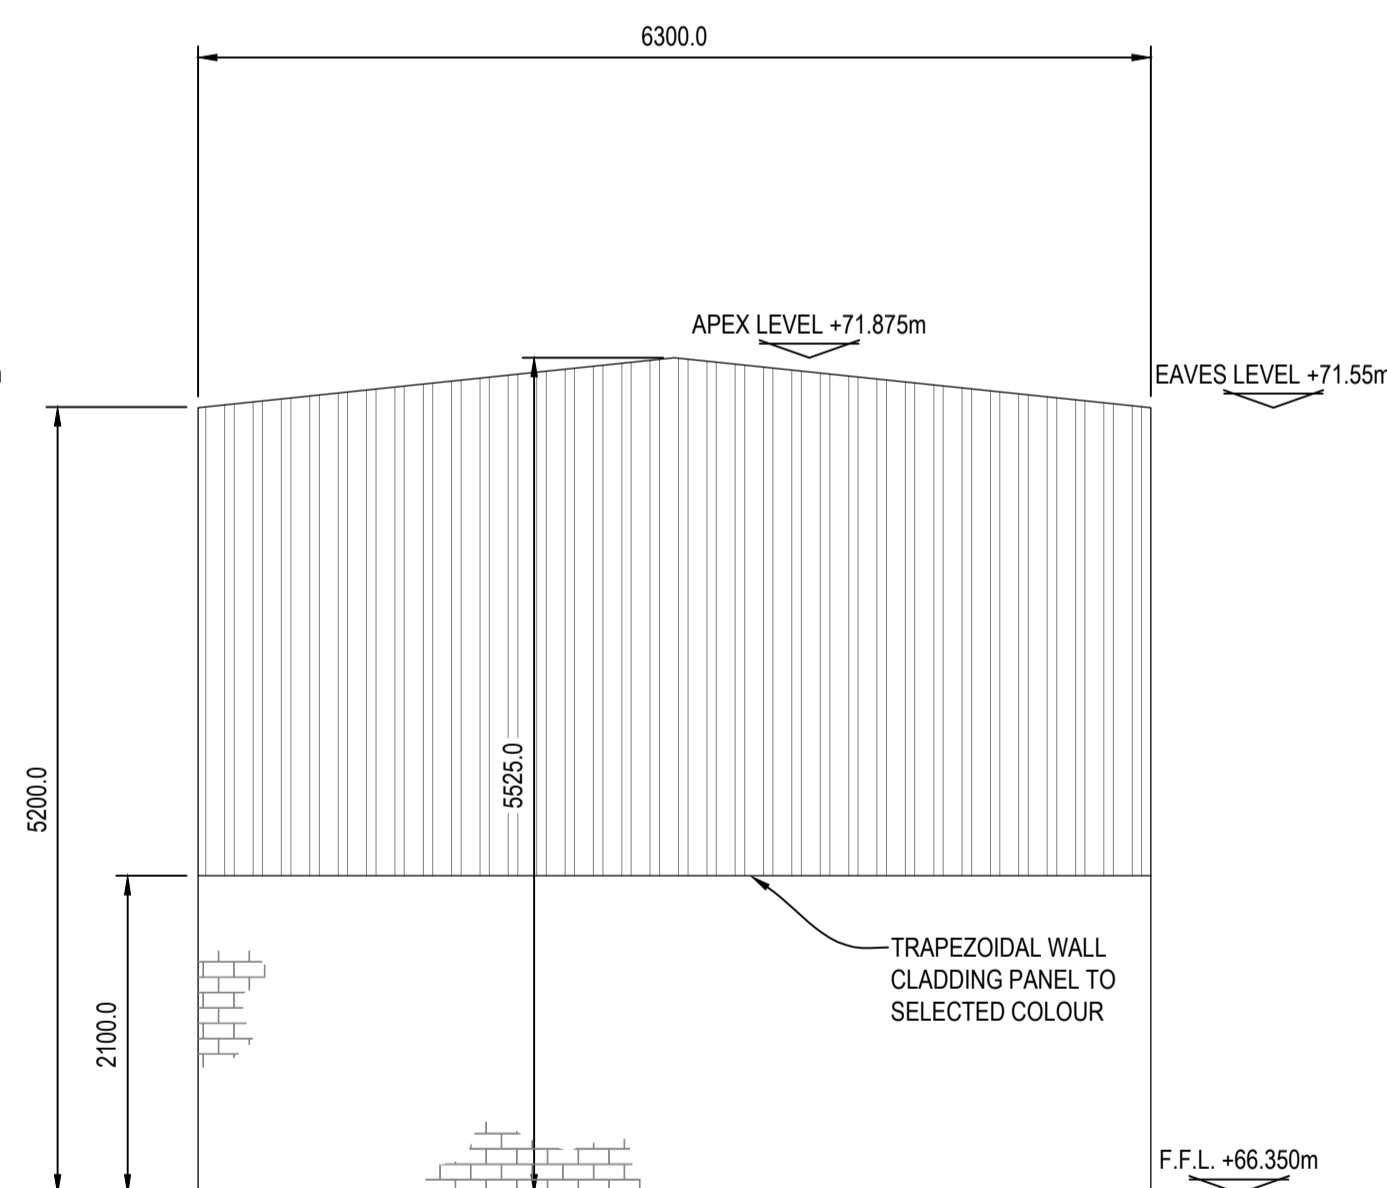

WEST ELEVATION
SCALE 1:50

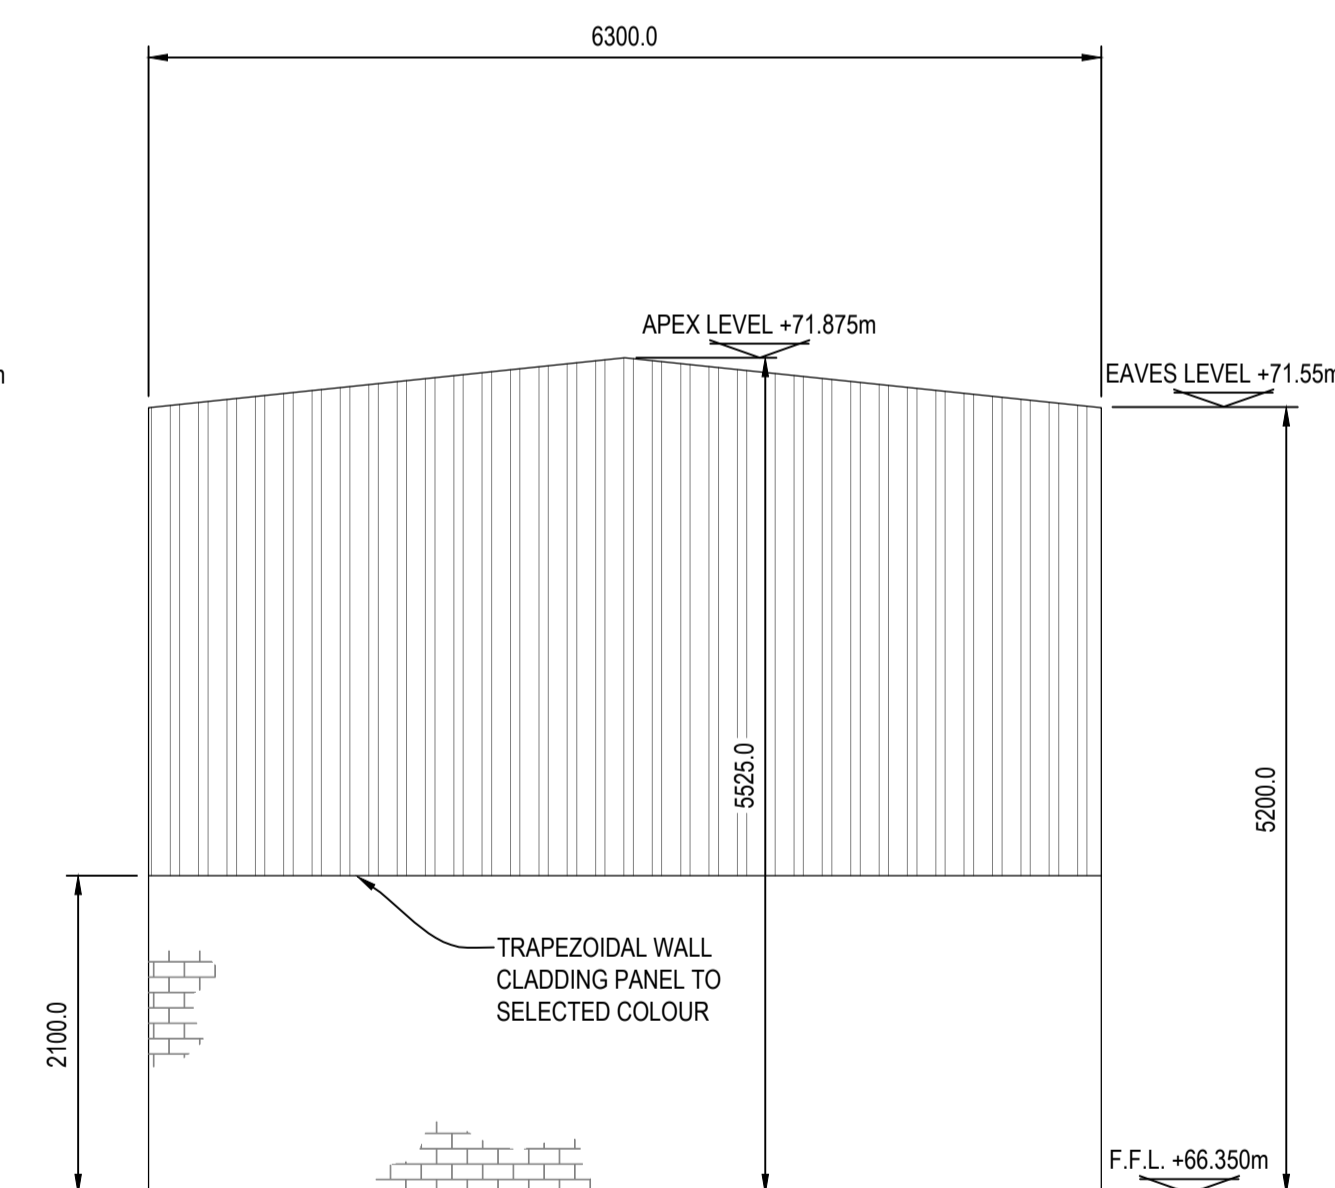

EAST ELEVATION
SCALE 1:50

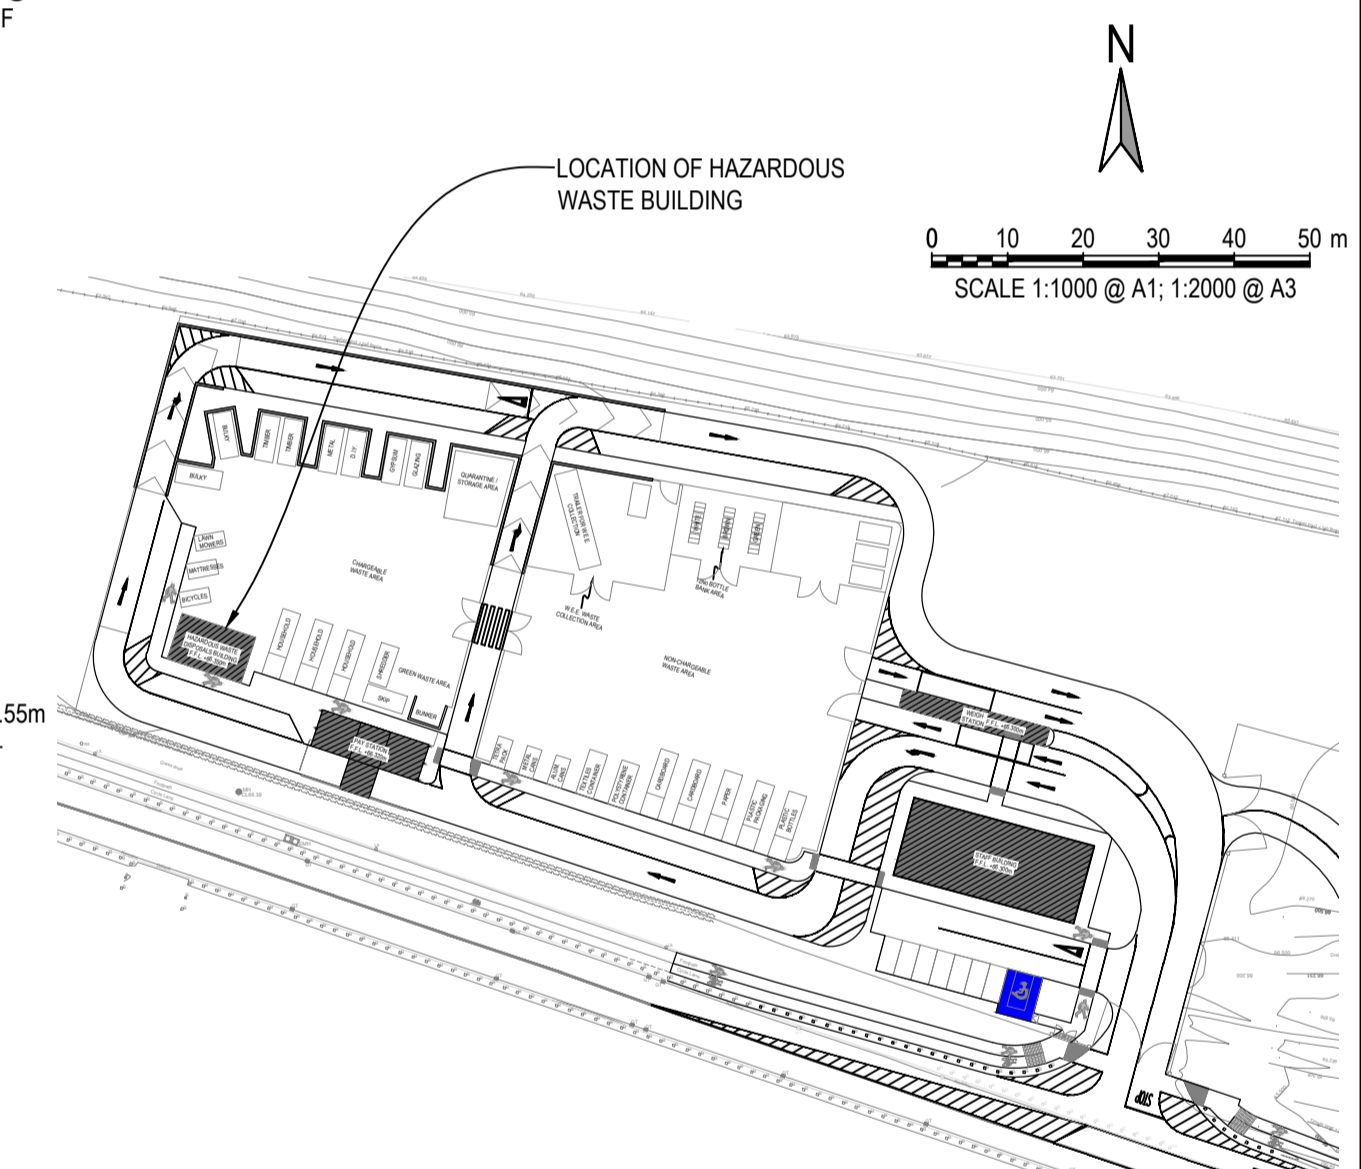

KEY PLAN
SCALE 1:1000

ISSUED FOR PLANNING

S2.P03	ISSUED FOR PLANNING	22.02.2019	KD	PD
S2.P02	ISSUED FOR INFORMATION	17.12.2018	KD	PD
S2.P01	ISSUED FOR INFORMATION	05.11.2018	KD	PD
Rev.	Note	Date	Drawn	Check

DONNACHADH O'BRIEN & ASSOCIATES CONSULTING ENGINEERS
 UNIT 5C ELM HOUSE MILLENNIUM PARK NAAS CO. KILDARE
 PHONE: +353 45 984 042
 INFO@DOBRIEN-ENGINEERS.IE WWW.DOBRIEN-ENGINEERS.IE

Client: KILDARE COUNTY COUNCIL
 Comhairle Chontae Chill Dara
 MR. JOE BOLAND, DIRECTOR OF SERVICES
 WATER SERVICES & ENVIRONMENT

Project: PROPOSED CIVIC AMENITY CENTRE & WASTE TRANSFER FACILITY AT KILMACREDDOCK UPPER, CASTLETOWN, CELBRIDGE, Co. KILDARE

Drawing Title: PROPOSED HOUSEHOLD HAZARDOUS WASTE BUILDING G.A's

Drawn By: KD	Checked By: PD	Approved By: DOB	Date: FEB' 2017	Scale: 1:50	Sheet Size: A1
Project Number: DOBA1701	Drawing Number: CIVAMY-DOB-XX-SI- DR-C-0018	Status Code: S2	Rev Number: P03		